



THIS DRAWING AND DETAIL ON IT IS AN INSTRUMENT OF SERVICE, IS THE
PROPERTY OF RUTGERS UNIVERSITY, AND MAY BE USED FOR THE PROJECT
INTENDED AND SHALL NOT BE REPRODUCED OR REPRODUCED WITHOUT
WRITTEN CONSENT OF RUTGERS UNIVERSITY.

KEY PLAN


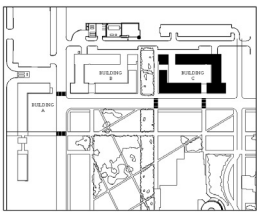


NO SCALE

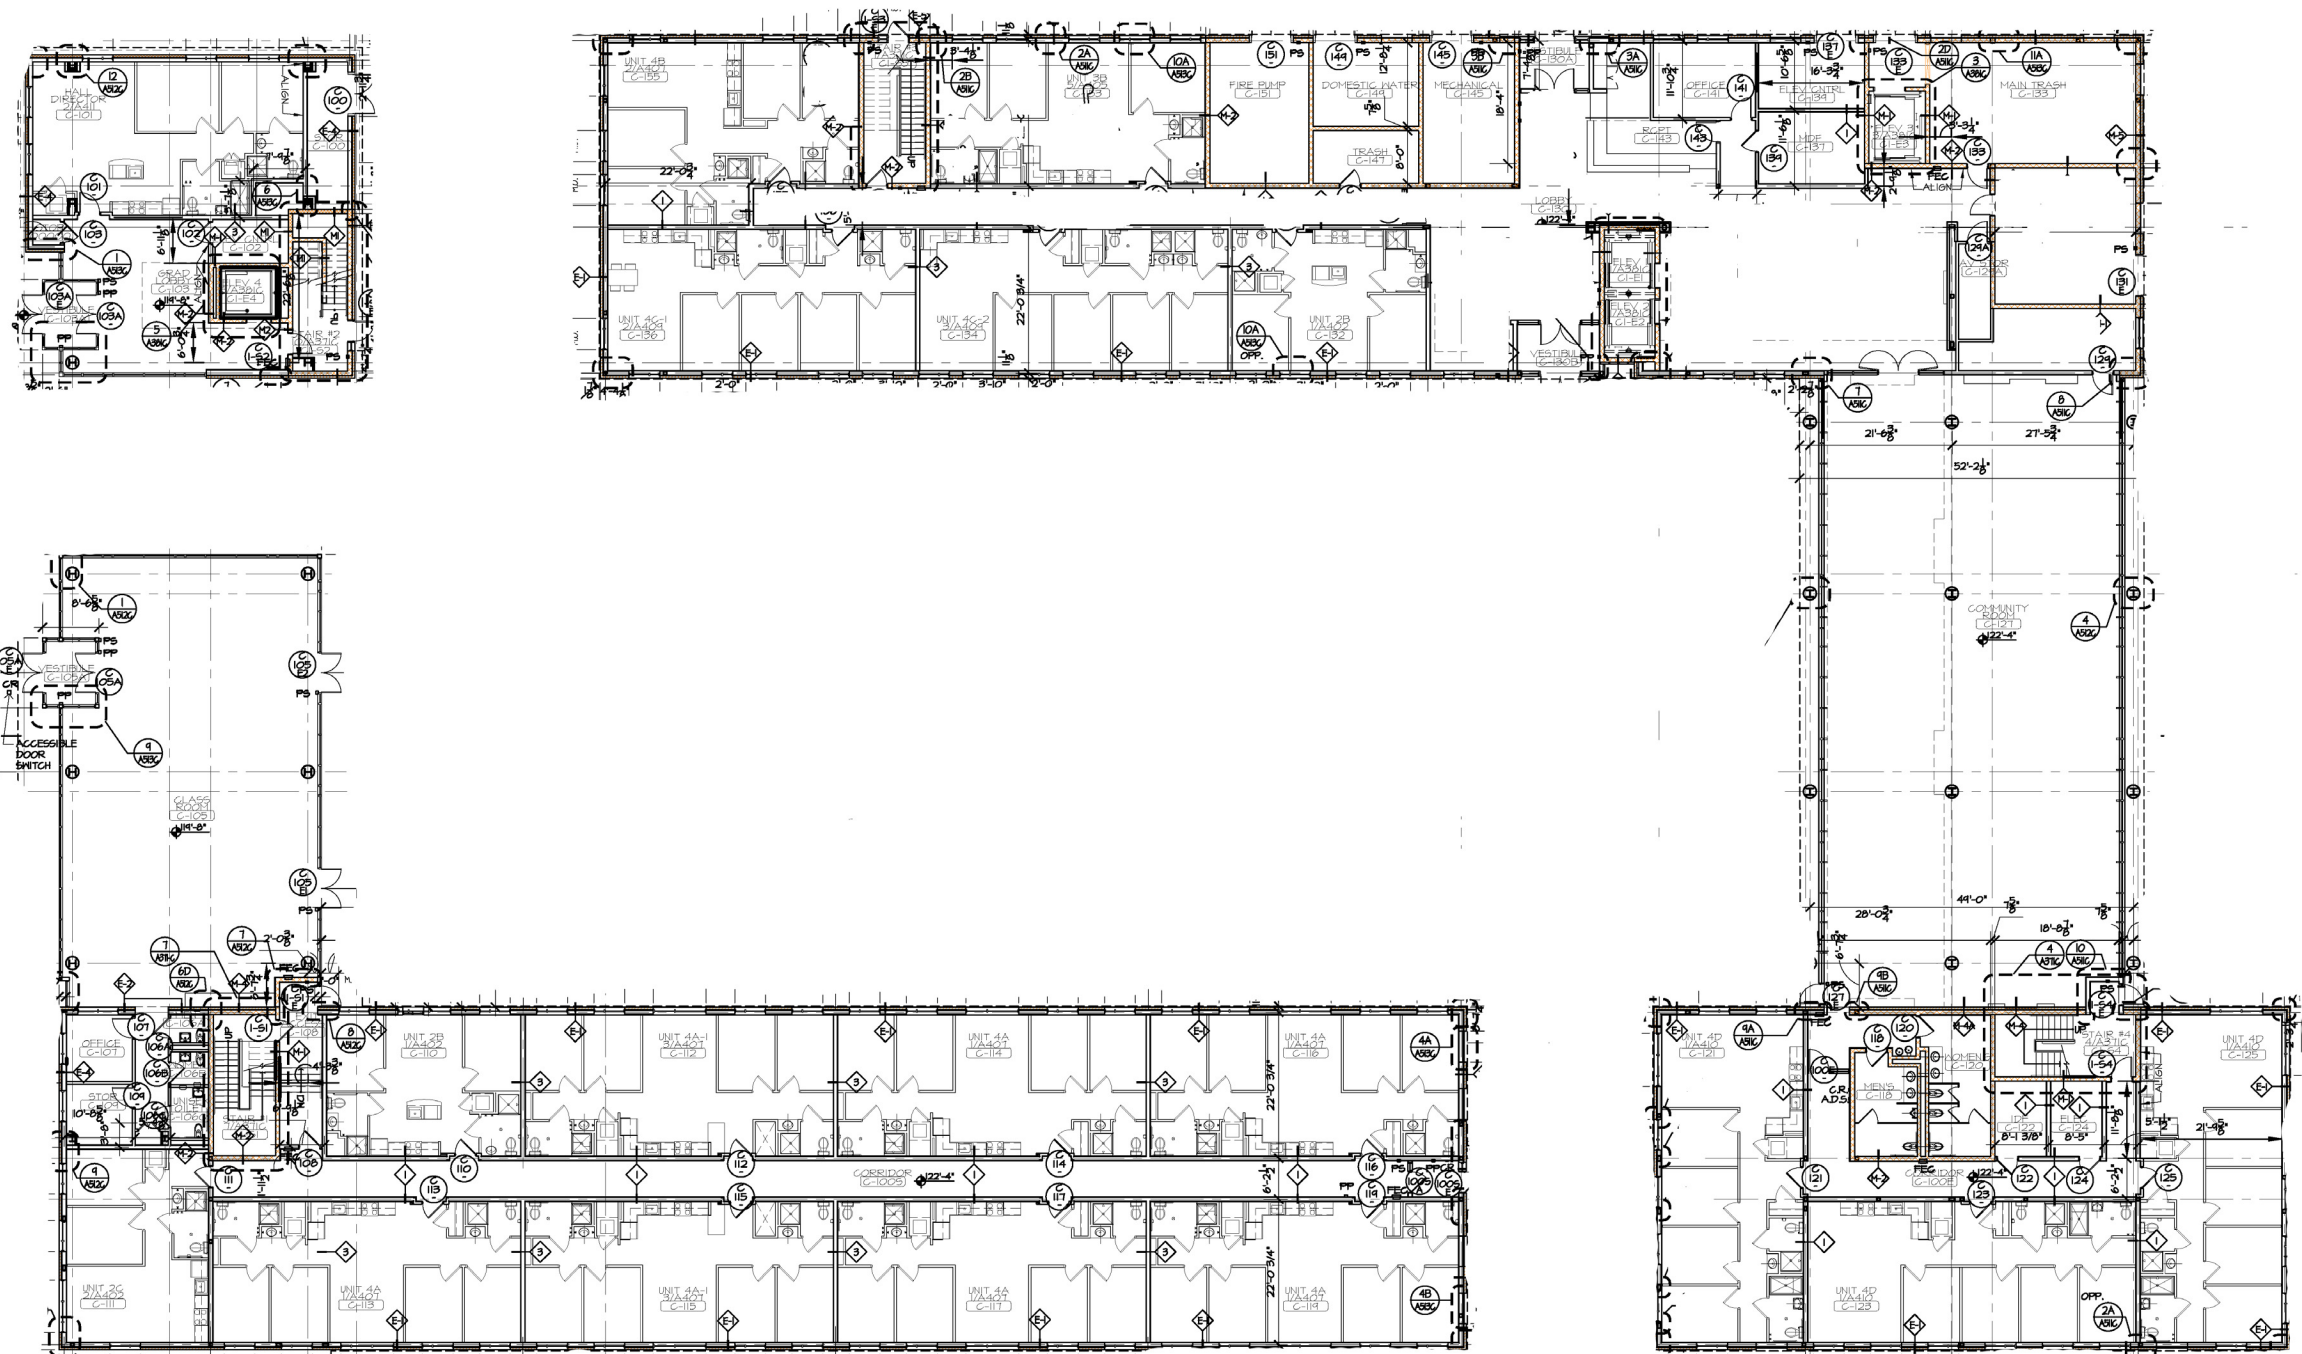


BUILDING C
LEVEL 1 - FLOOR PLAN
A101C SCALE: 3/32" = 1'-0"

PROJECT TITLE		
LIVINGSTON NEW HOUSING PROJECT		
FOR BID / FOR CONTRACT SET		
DRAWING TITLE		
BLDG C LEVEL 1 FLOOR PLAN		
BLDG. NO.	DSR. NO.	DRAWN BY
4179	0011-09-BI	SK
SCALE	DATE	CHECKED BY
3/32" = 1'-0"	01-04-2010	HF
PROJ. NO.: FT-E090590 / DCI-333-09		
DRAWING NUMBER		
A101C		

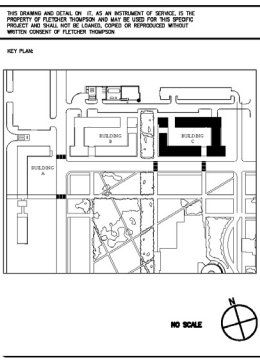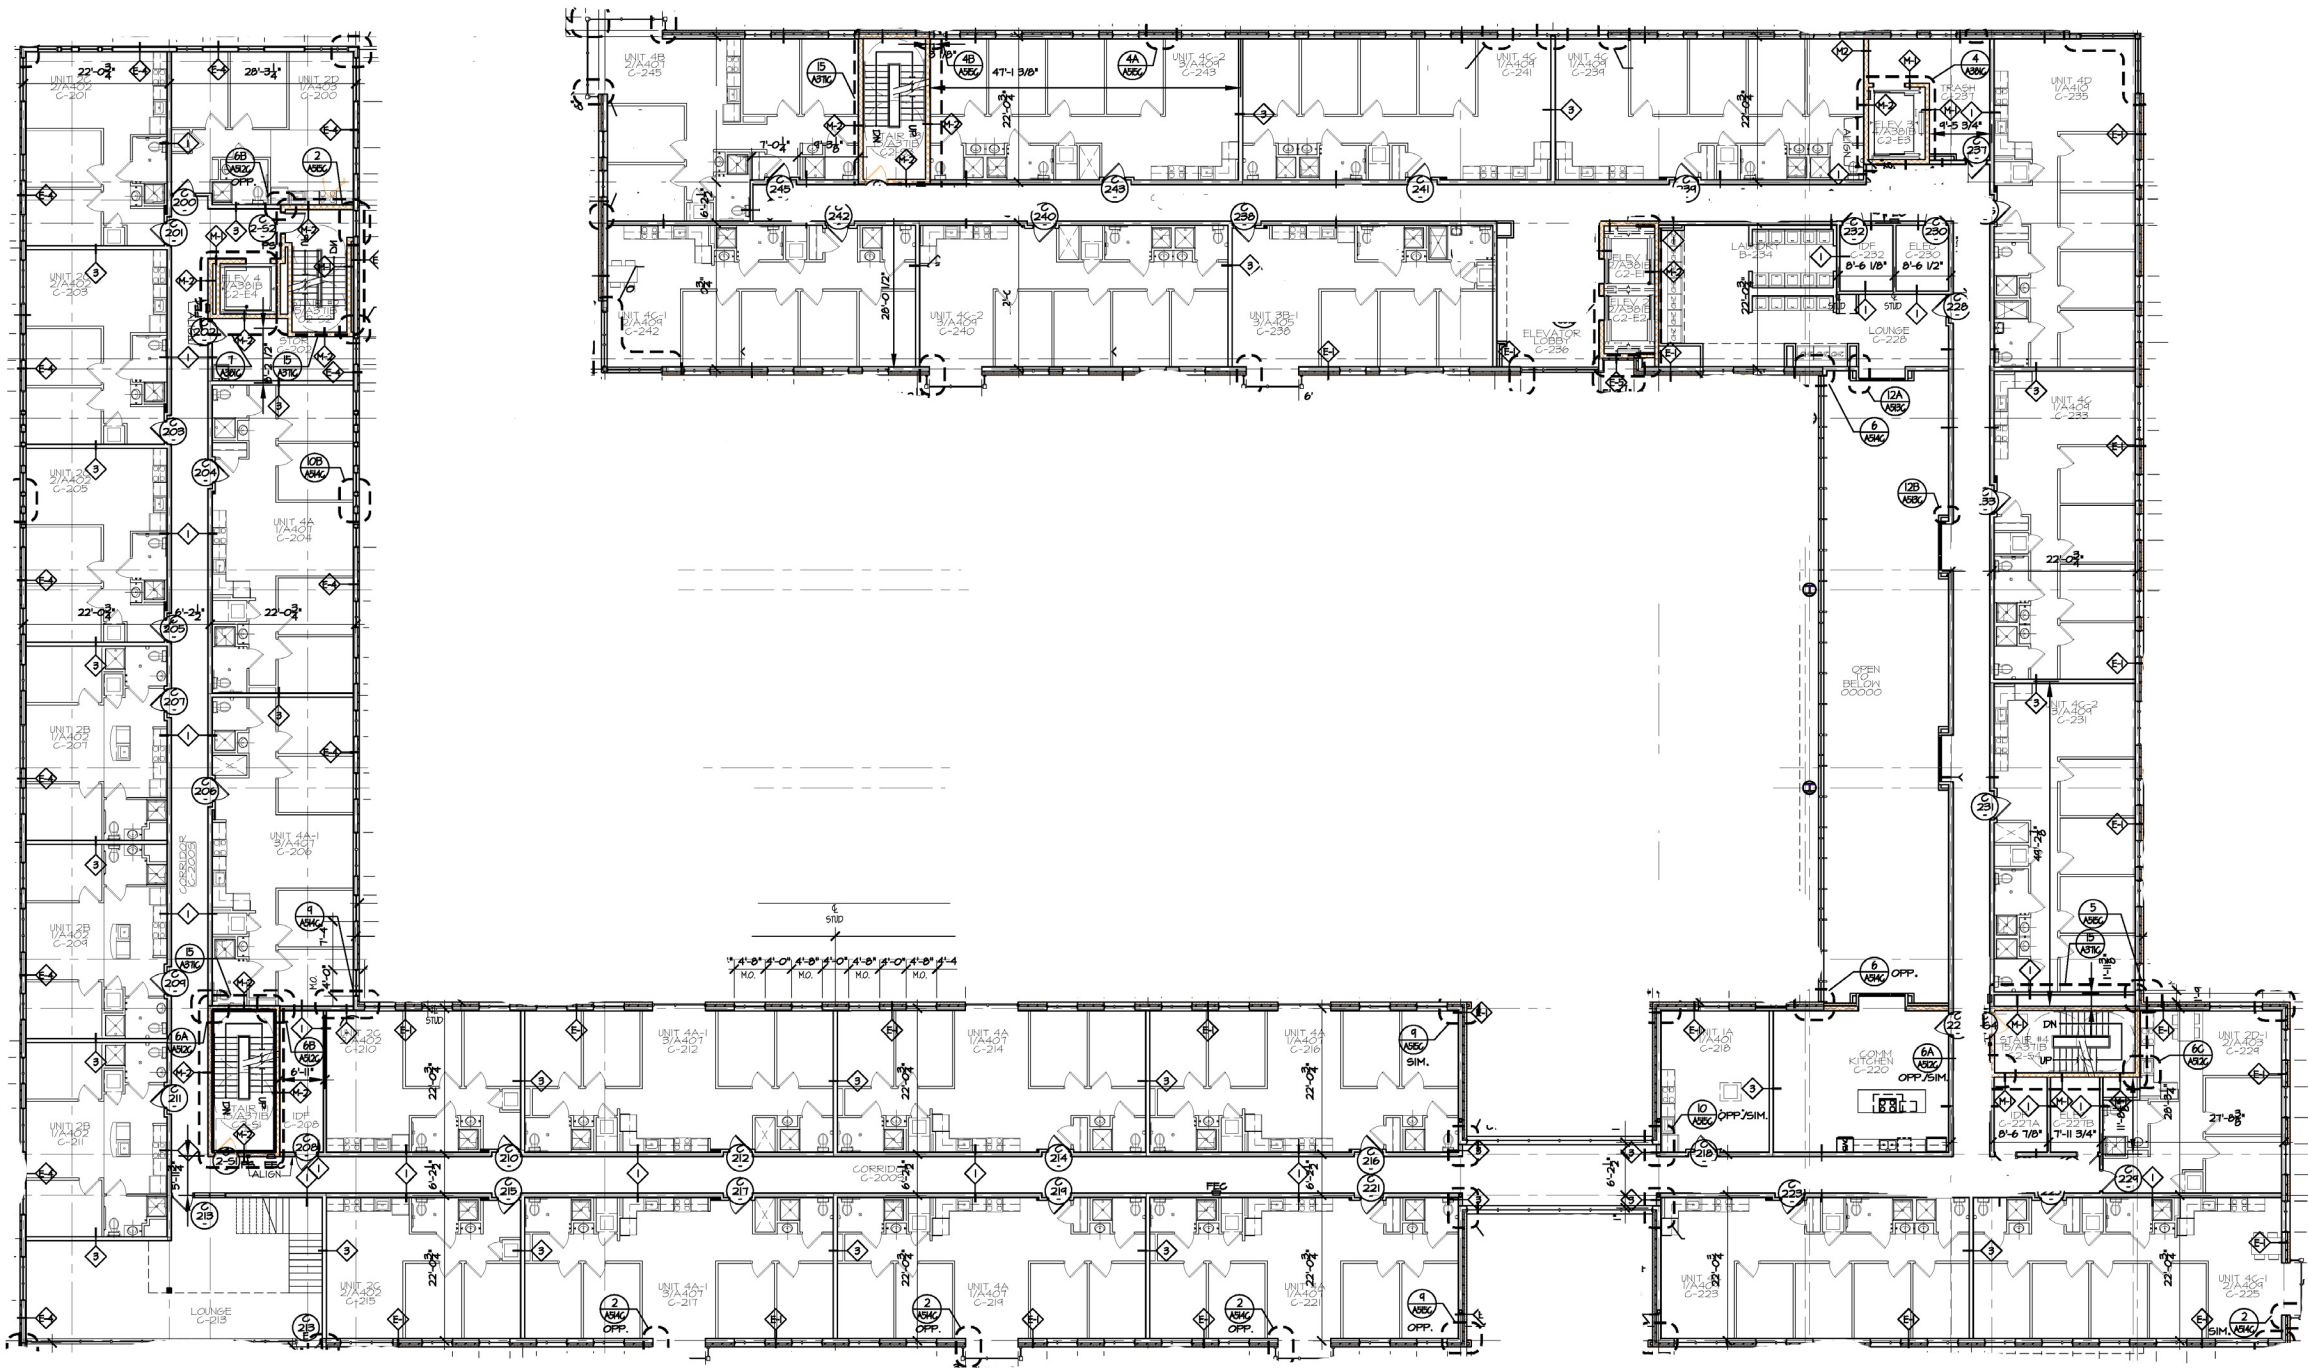


BUILDING C
LEVEL 2 - FLOOR PLAN
1
A102C SCALE: 3/32" = 1'-0"

PROJECT TITLE		
LIVINGSTON NEW HOUSING PROJECT		
FOR BID / FOR CONTRACT SET		
DRAWING TITLE		
BLDG C LEVEL 2 FLOOR PLAN		
BLDG. NO.	DSR. NO.	DRAWN BY
4179	0011-09-BI	SK
SCALE	DATE	CHECKED BY
3/32" = 1'-0"	01-04-2010	HF
PROJ. NO. FT-E090590 / DCI-333-09		
DRAWING NUMBER		
A102C		

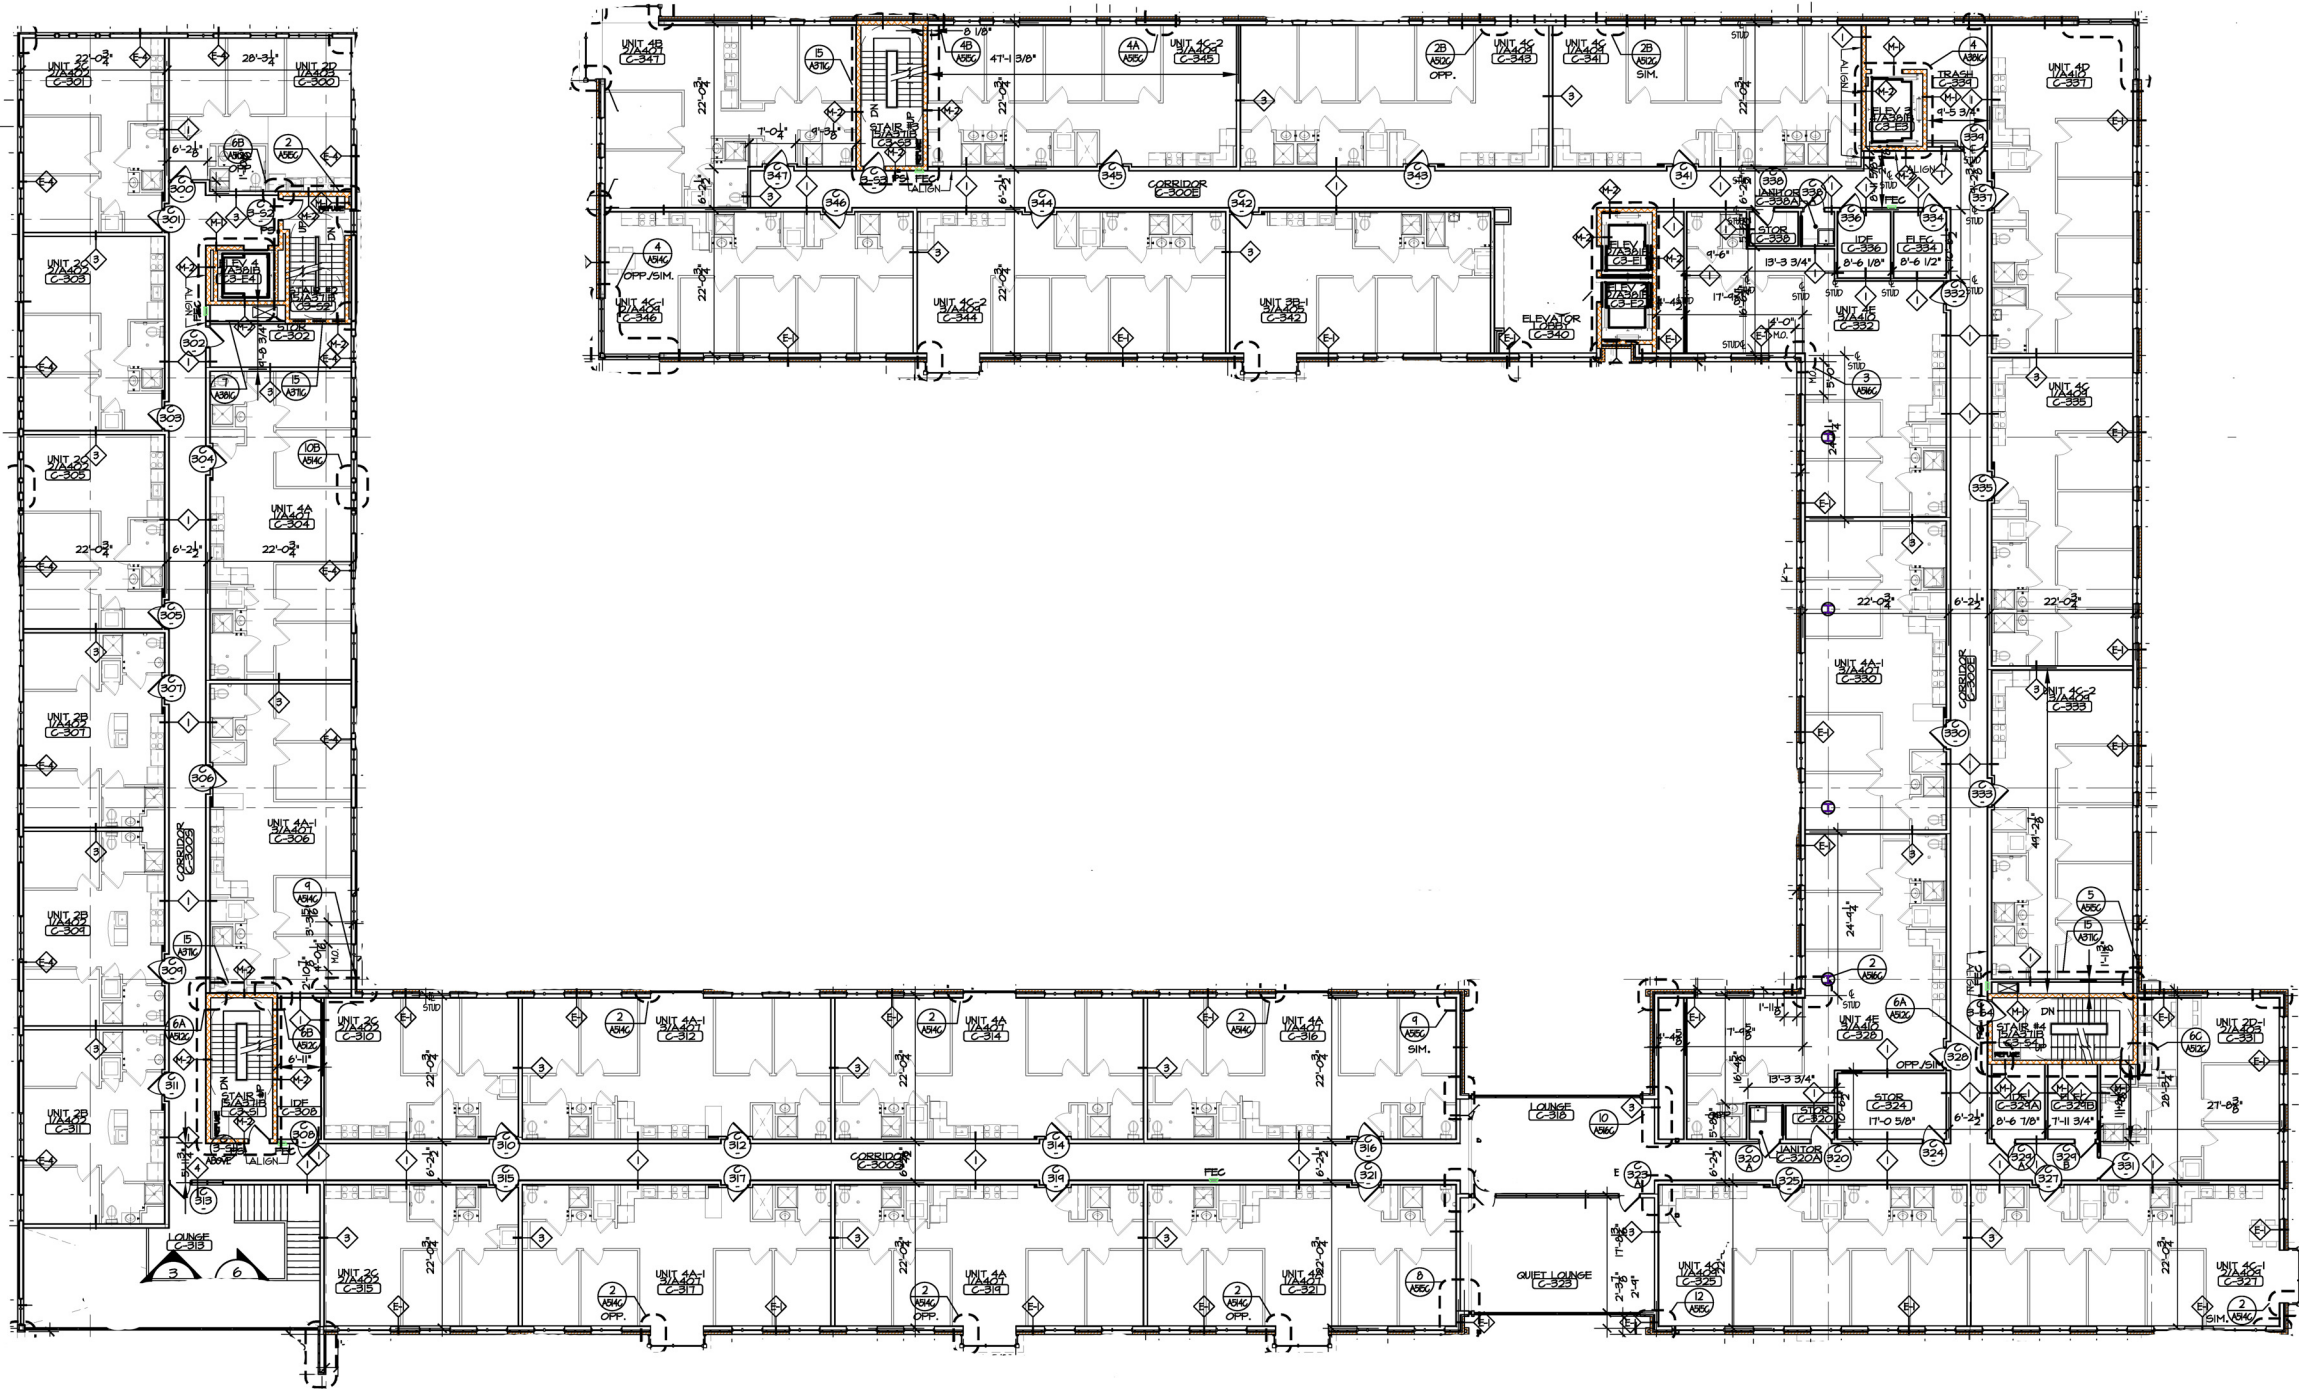

THIS DRAWING AND DETAIL ON IT IS AN INSTRUMENT OF SERVICE, IS THE PROPERTY OF RUTGERS UNIVERSITY, AND MAY BE USED FOR THE PROJECT, PROJECT AND SHALL NOT BE COPIED, REPRODUCED OR REPRODUCED WITHOUT THE WRITTEN CONSENT OF RUTGERS UNIVERSITY.

KEY PLAN

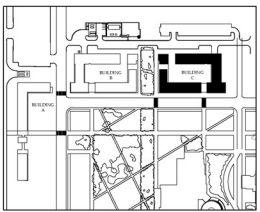

NO SCALE




1
A103C
BUILDING C
LEVEL 3 - FLOOR PLAN
SCALE: 3/32" = 1'-0"


DRAWING TITLE		
BLDG C LEVEL 3 FLOOR PLAN		
BLDG. NO.	DSR NO.	DRAWN BY
4179	0011-09-BJ	SK
SCALE	DATE	CHECKED BY
3/32"=1'-0"	01-04-2010	HF
PROJ. NO: FT-E090590 / DCI-333-09		
DRAWING NUMBER		
A103C		

THIS DRAWING AND DETAIL ON IT IS AN INSTRUMENT OF SERVICE, IS THE
PROPERTY OF RUTGERS UNIVERSITY AND MAY BE USED FOR THE PROJECT
INDICATED AND SHALL NOT BE COPIED, REPRODUCED OR REPRODUCED WITHOUT
WRITTEN CONSENT OF RUTGERS UNIVERSITY.

KEY PLAN


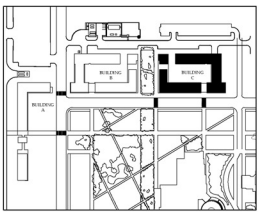


NO SCALE

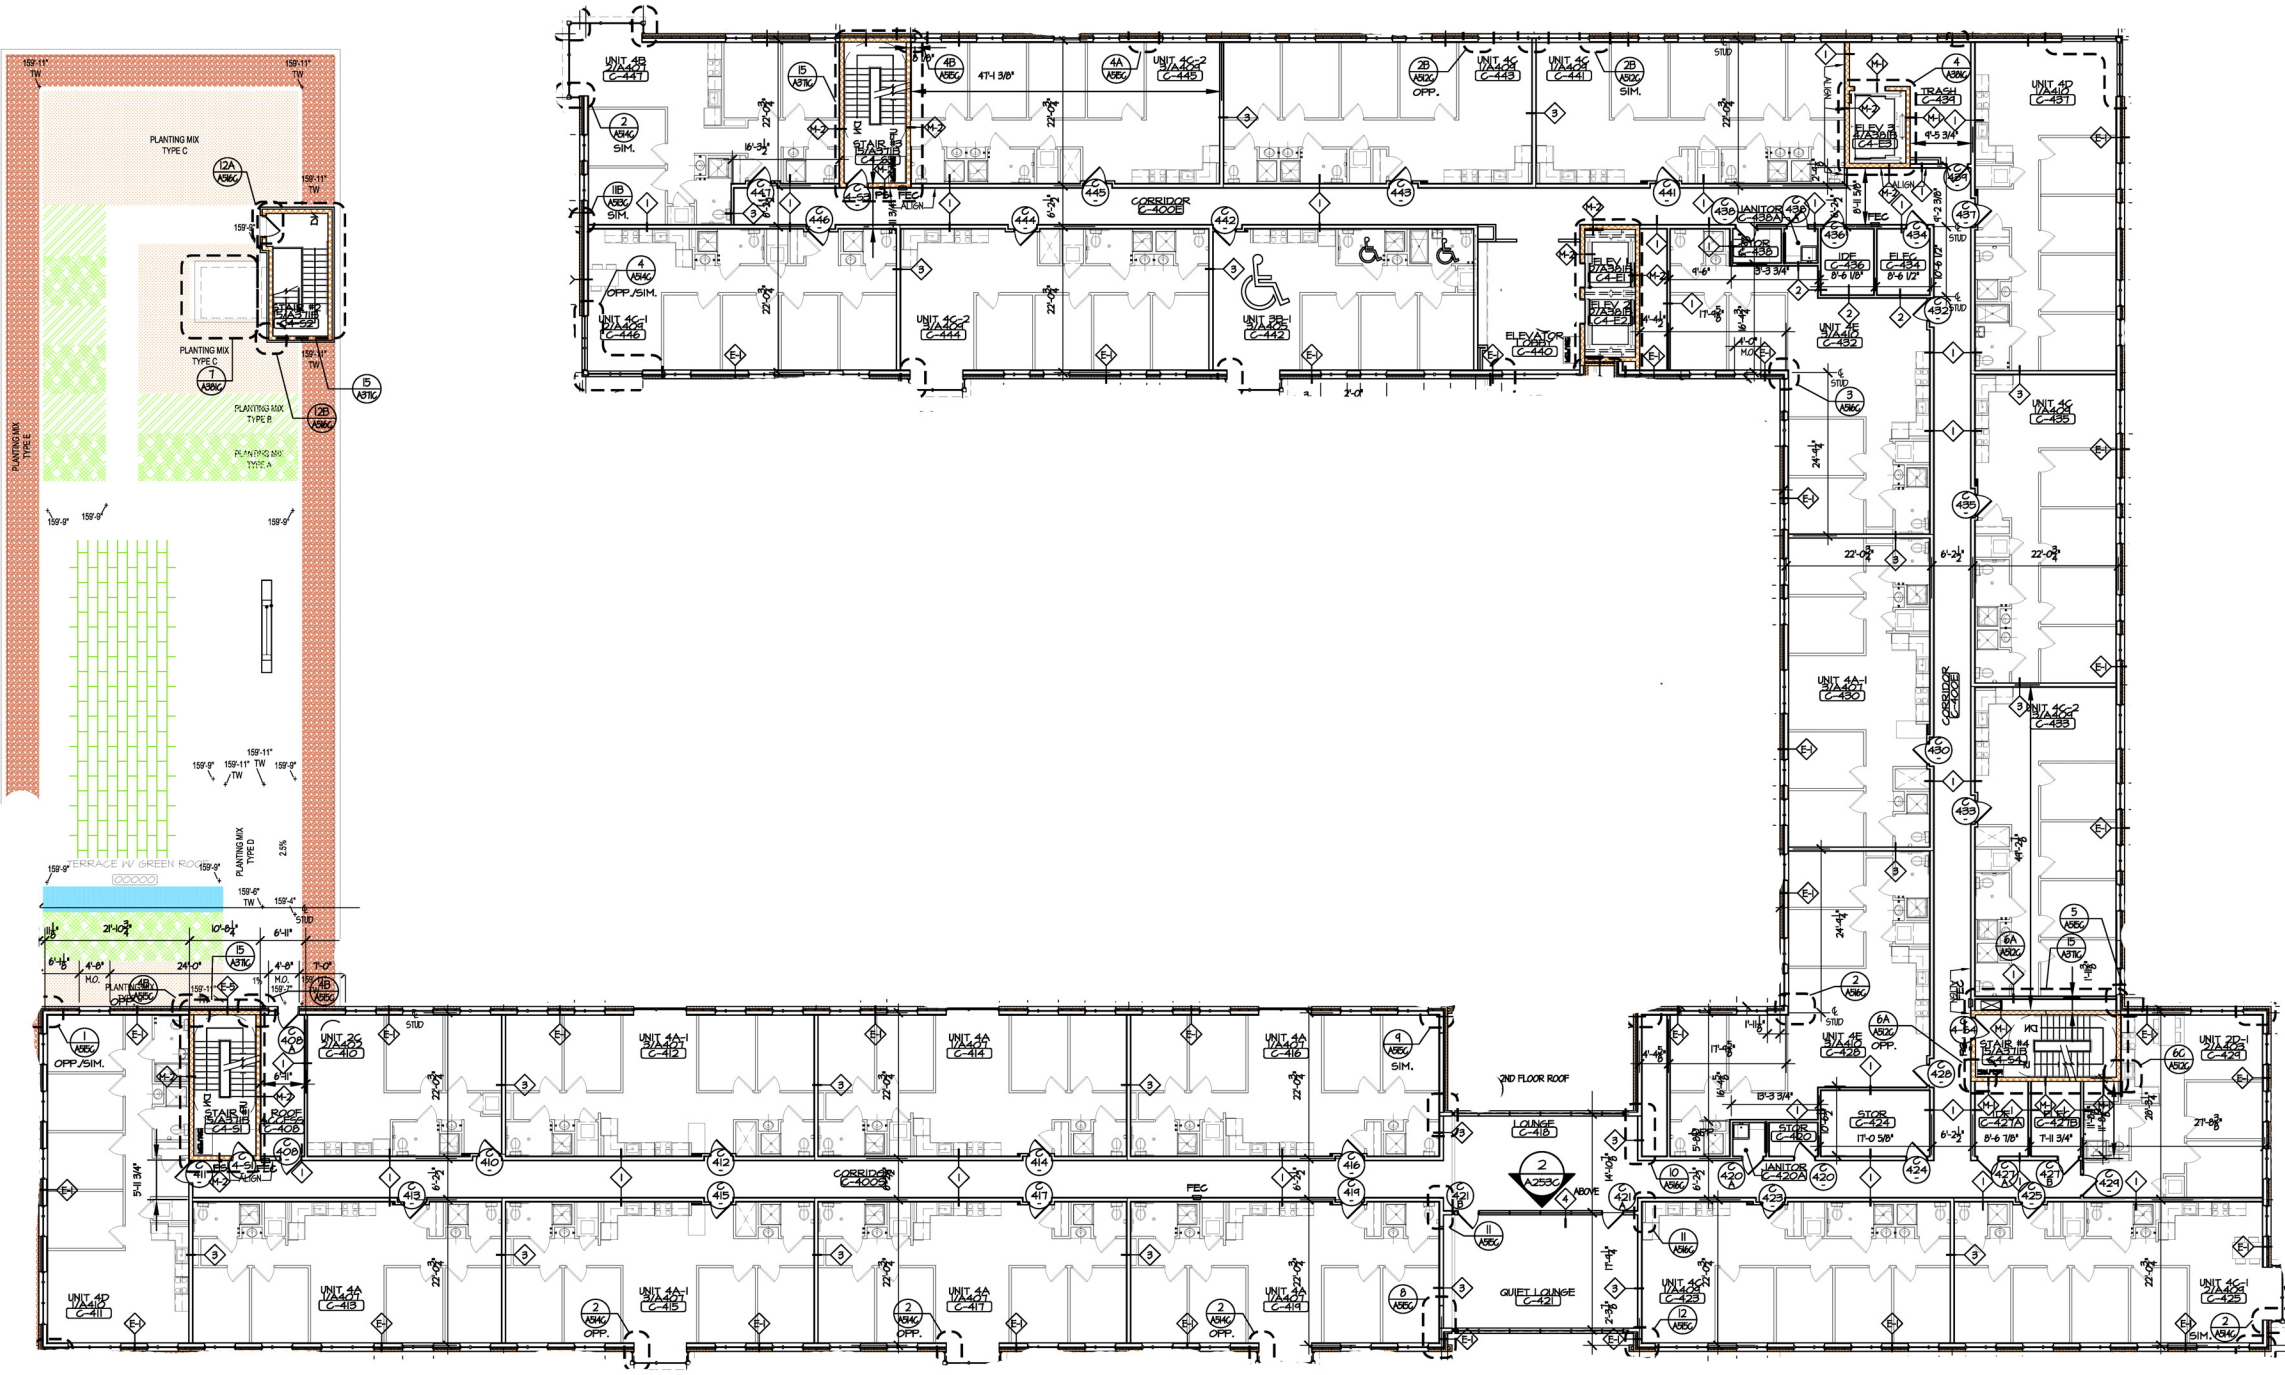


1 BUILDING C
LEVEL 4 - FLOOR PLAN
SCALE: 3/32" = 1'-0"

PROJECT TITLE		
LIVINGSTON NEW HOUSING PROJECT		
FOR BID / FOR CONTRACT SET		
DRAWING TITLE		
BLDG C LEVEL 4 FLOOR PLAN		
BLDG. NO.	DSR NO.	DRAWN BY
4179	0011-09-BJ	SK
SCALE	DATE	CHECKED BY
3/32" = 1'-0"	01-04-2010	HIF
PROJ. NO: FT-E090590 / DCI-333-09		
DRAWING NUMBER		
A104C		

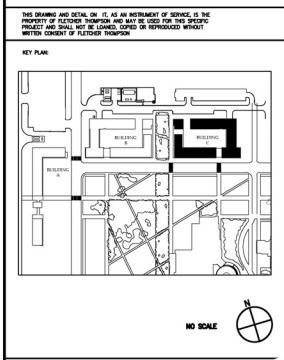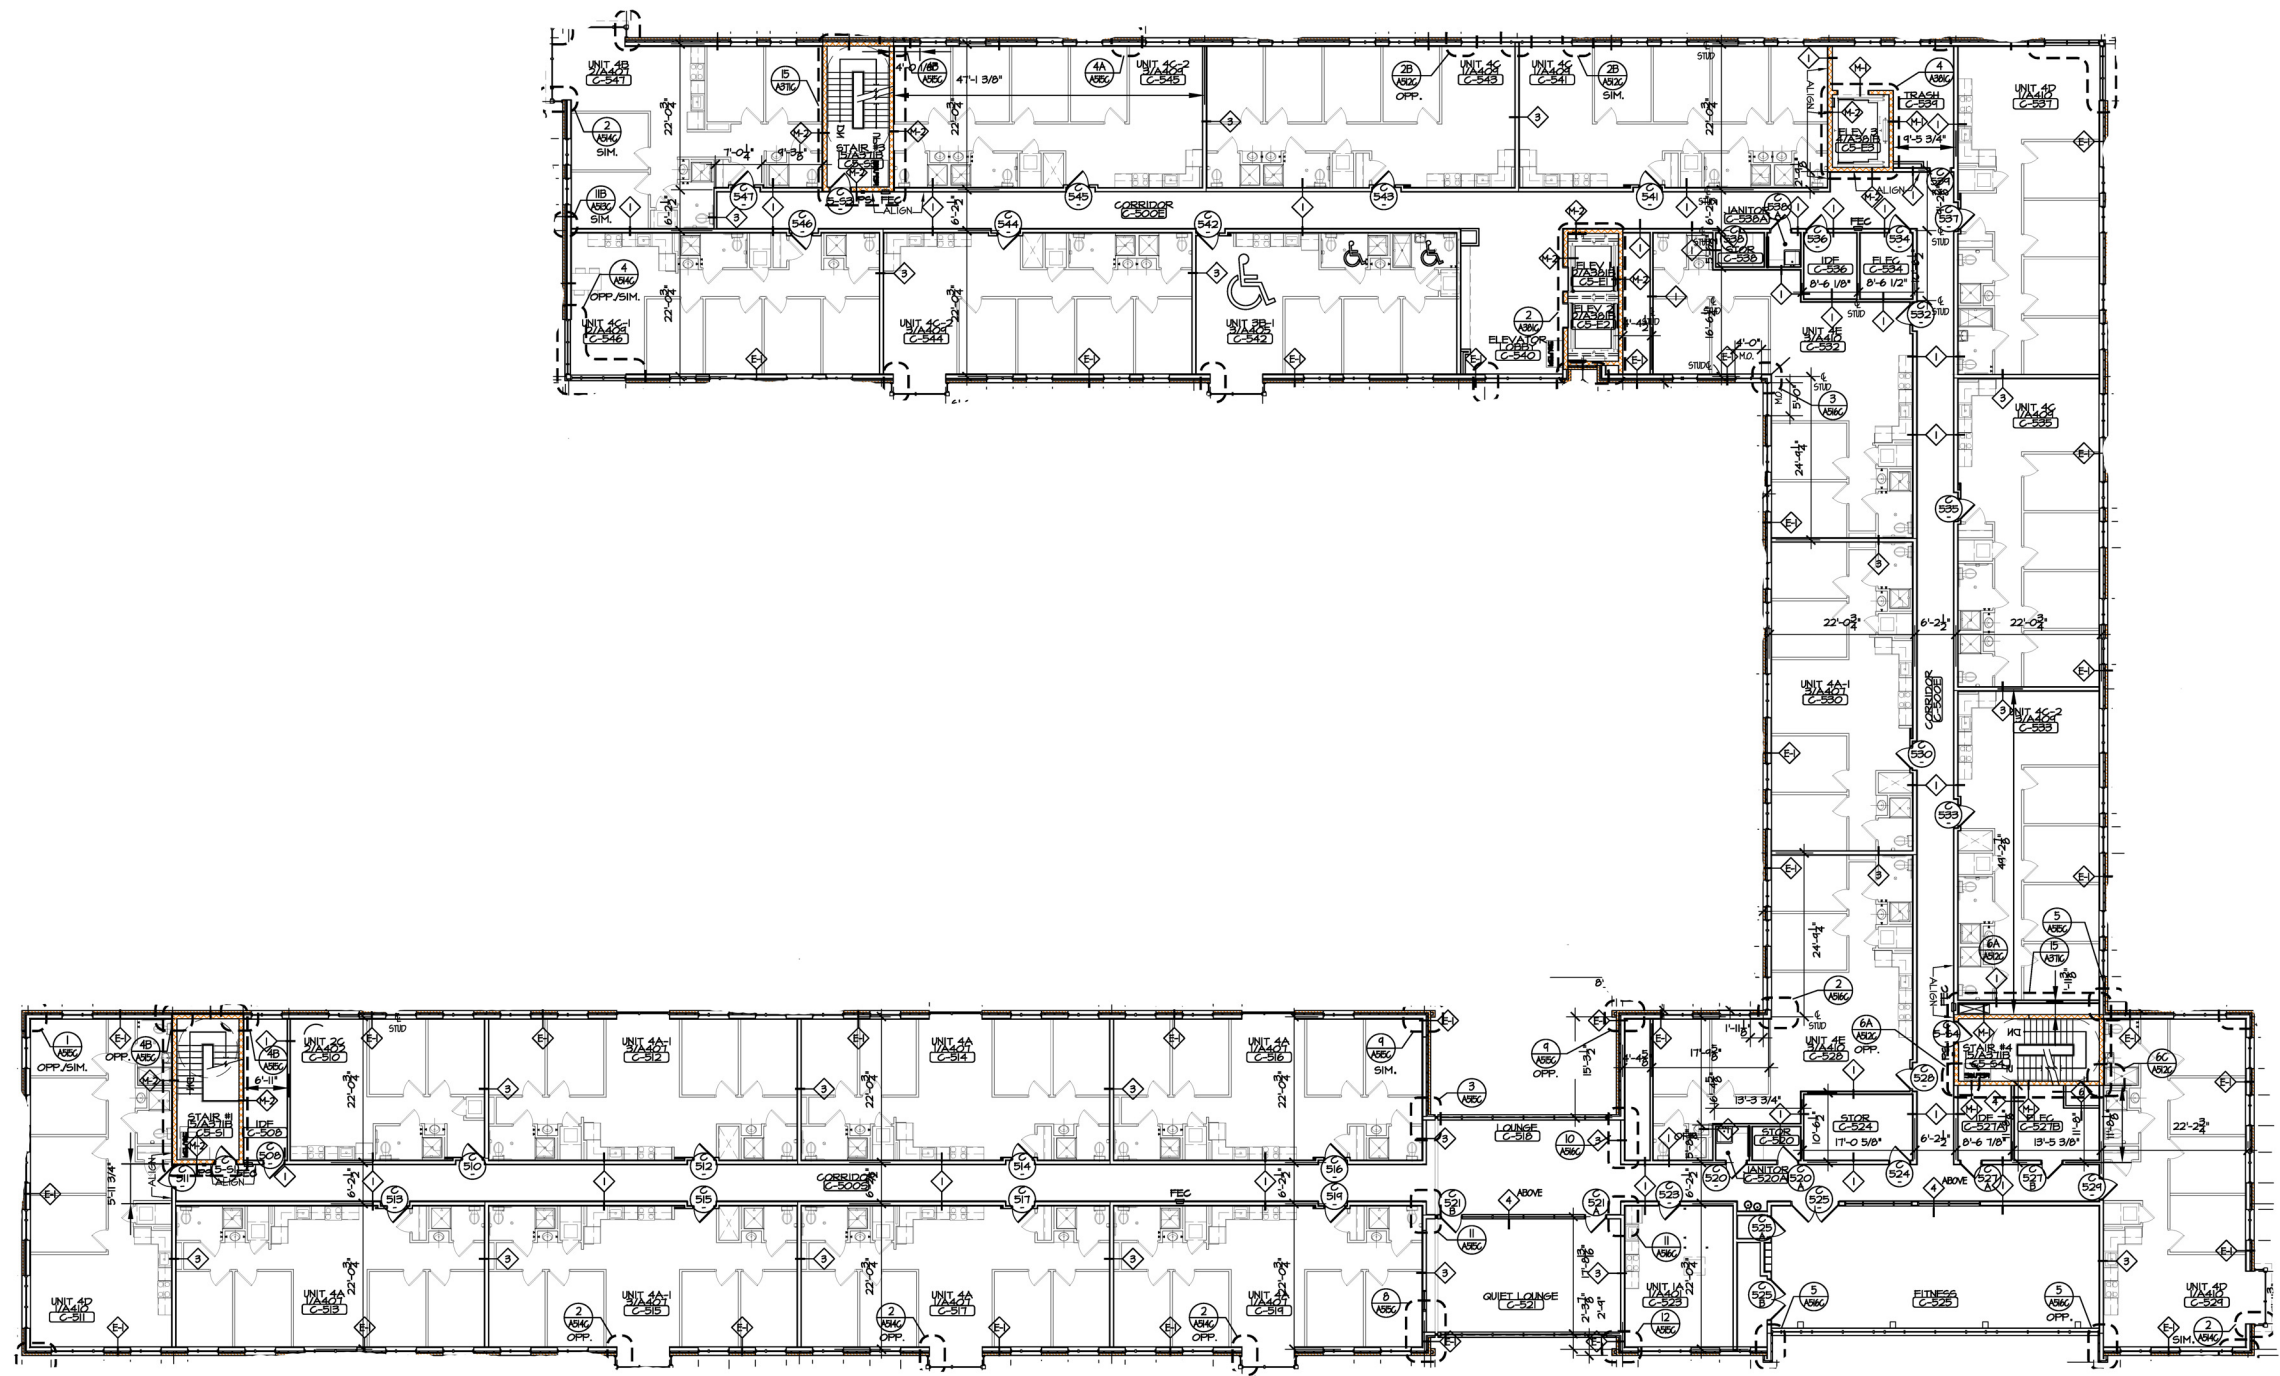

BUILDING C
LEVEL 5 - FLOOR PLAN
1
A105C SCALE: 3/32" = 1'-0"


DRAWING TITLE		
BLDG C LEVEL 5 FLOOR PLAN		
BLDG. NO.	DSR NO.	DRAWN BY
4179	0011-09-BJ	SK
SCALE	DATE	CHECKED BY
3/32" = 1'-0"	01-04-2010	HIF
PROJ. NO: FT-E090590 / DCI-333-09		
DRAWING NUMBER		
A105C		

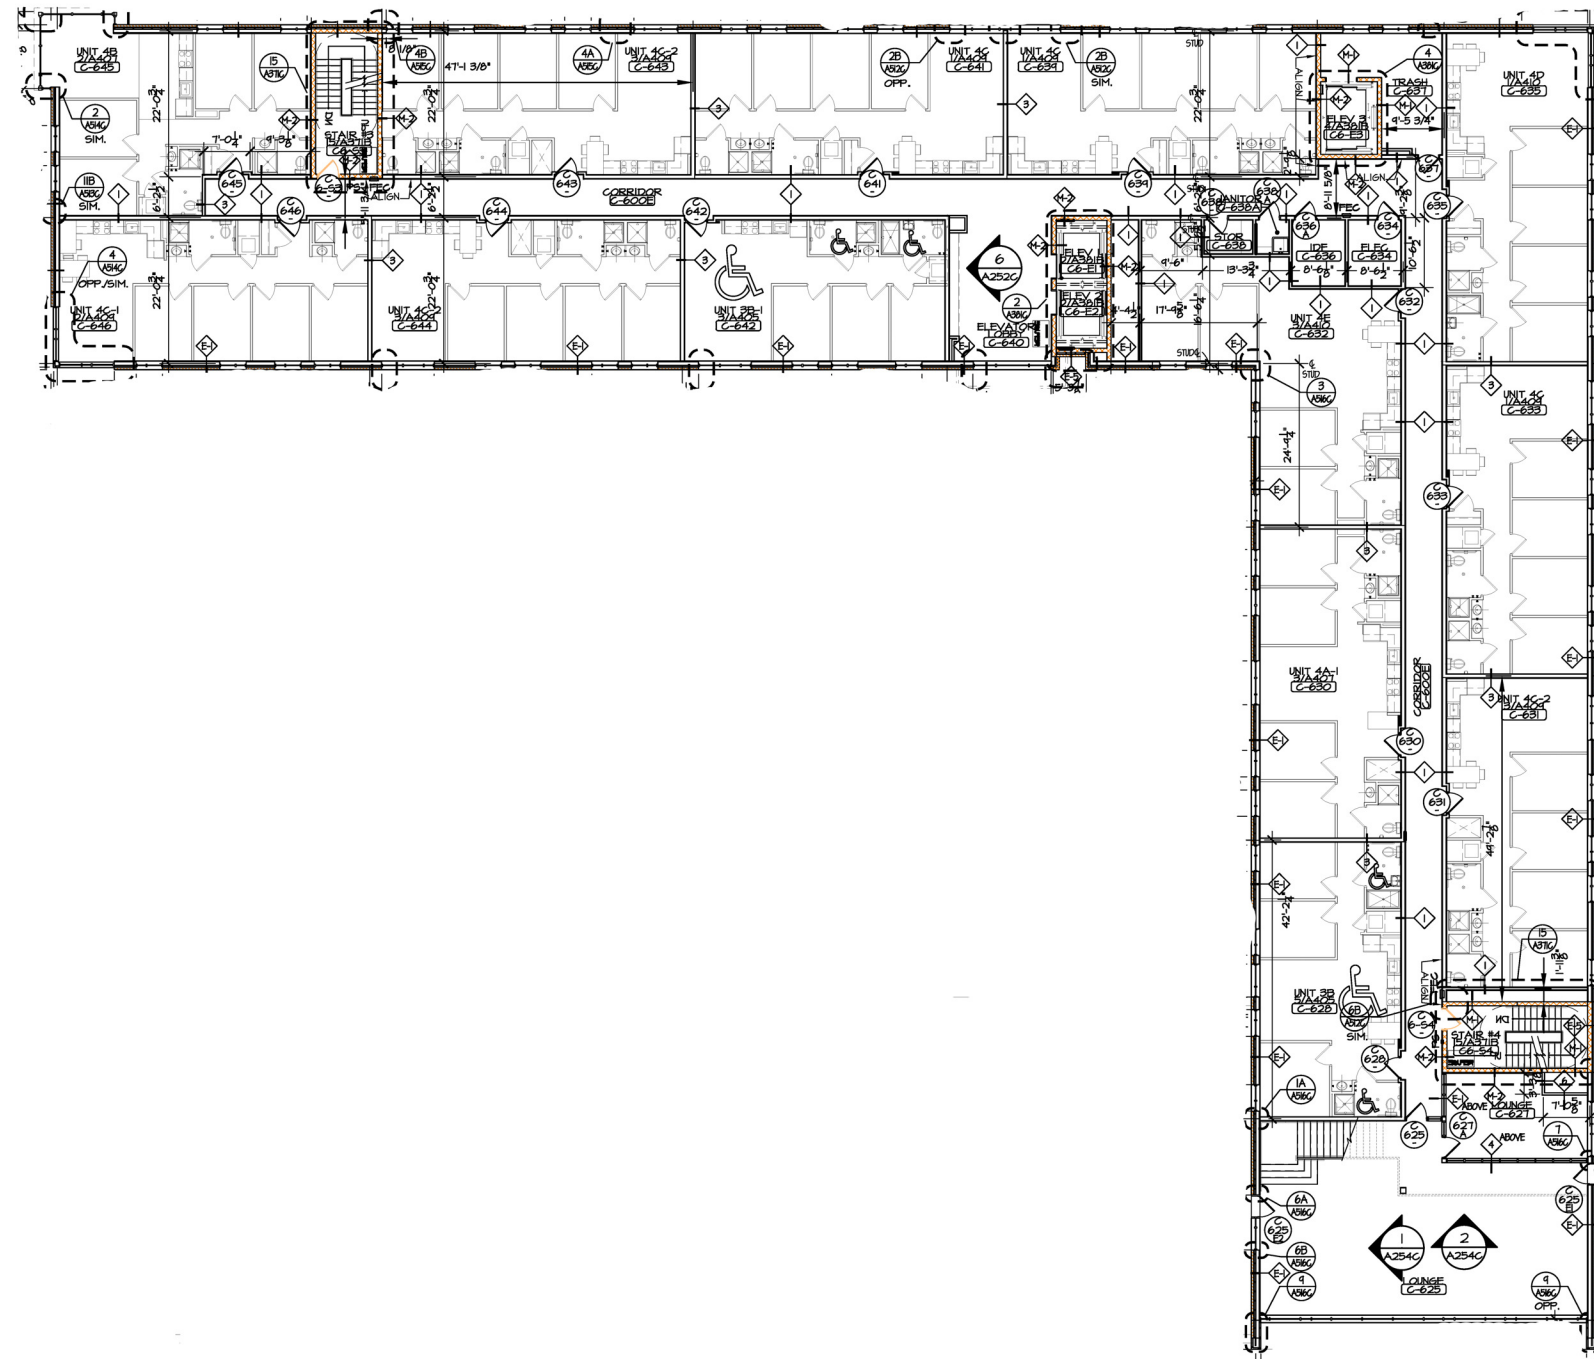

BUILDING C
LEVEL 6 - FLOOR PLAN
SCALE: 3/32" = 1'-0"

THIS DRAWING AND DETAIL ON IT, AS AN INSTRUMENT OF SERVICE, IS THE PROPERTY OF FLETCHER THOMPSON AND MAY BE USED FOR THIS SPECIFIC PROJECT AND SHALL NOT BE LOANED, COPIED OR REPRODUCED WITHOUT WRITTEN CONSENT OF FLETCHER THOMPSON

KEY PLAN:

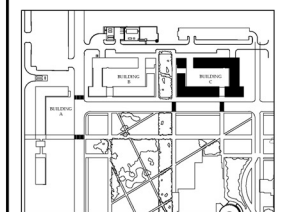

NO SCALE

APPROVED FOR RUTGERS-THE STATE UNIVERSITY OF NEW JERSEY

Jeff Livingston, P.A. 06/25/10
JEFF LIVINGSTON, P.A.
UNIVERSITY ARCHITECT
DATE

OFFICE OF UNIVERSITY FACILITIES
PISCATAWAY, NEW JERSEY

PROJECT TITLE
LIVINGSTON NEW
HOUSING PROJECT
FOR BID / FOR CONTRACT SET

DRAWING TITLE

BLDG C
LEVEL 6 FLOOR PLAN

BLDG. NO. 4179	DSR NO: 0011-09-BL	DRAWN BY SK
SCALE 3/32" = 1' - 0"	DATE 01-04-2010	CHECKED BY HF

PROJ. NO:	FT-E090590 / DCI-333-09
-----------	-------------------------



DRAWING NUMBER

DRAWING NUMBER

A 106C

A106C

	100
--	------------

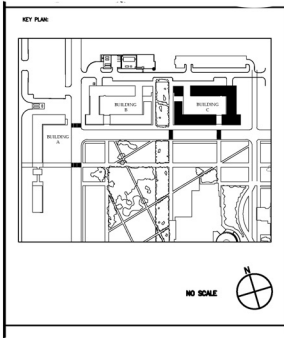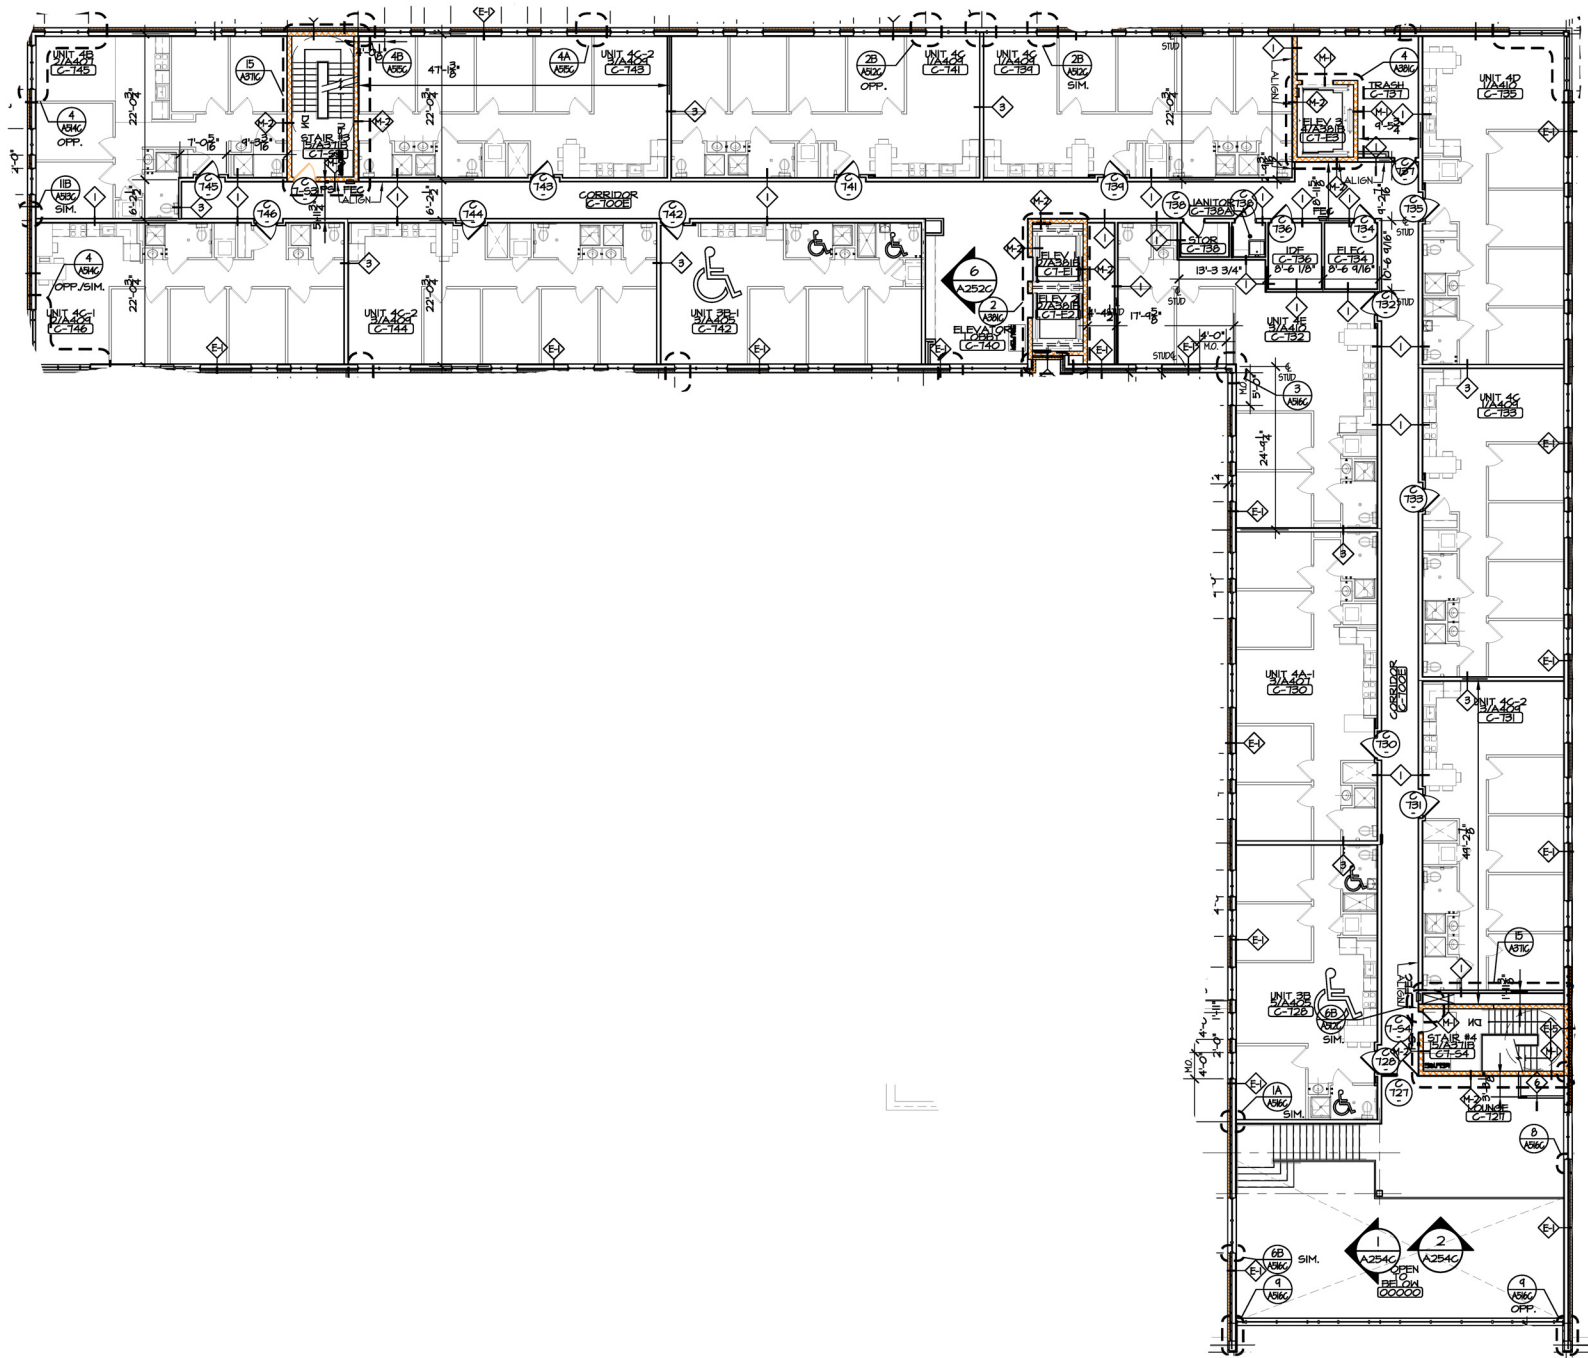

BUILDING C
LEVEL 7 - FLOOR PLAN
SCALE: 3/32" = 1'-0"

PROJECT TITLE		
LIVINGSTON NEW HOUSING PROJECT		
FOR BID / FOR CONTRACT SET		
DRAWING TITLE		
BLDG C LEVEL 7 FLOOR PLAN		
BLDG. NO.	DSR NO.	DRAWN BY
4179	0011-09-BL	SC
SCALE	DATE	CHECKED BY
3/32"=1'-0"	12-18-2009	HF
PROJ. NO: FT-E090590 / DCI-333-09		
DRAWING NUMBER		
A107C		